



UNITED STATES DEPARTMENT OF THE INTERIOR BUREAU OF INDIAN AFFAIRS


MARTY INDIAN SCHOOL - FI&R YANKTON SIOUX TRIBE MARTY, SOUTH DAKOTA Y9A04

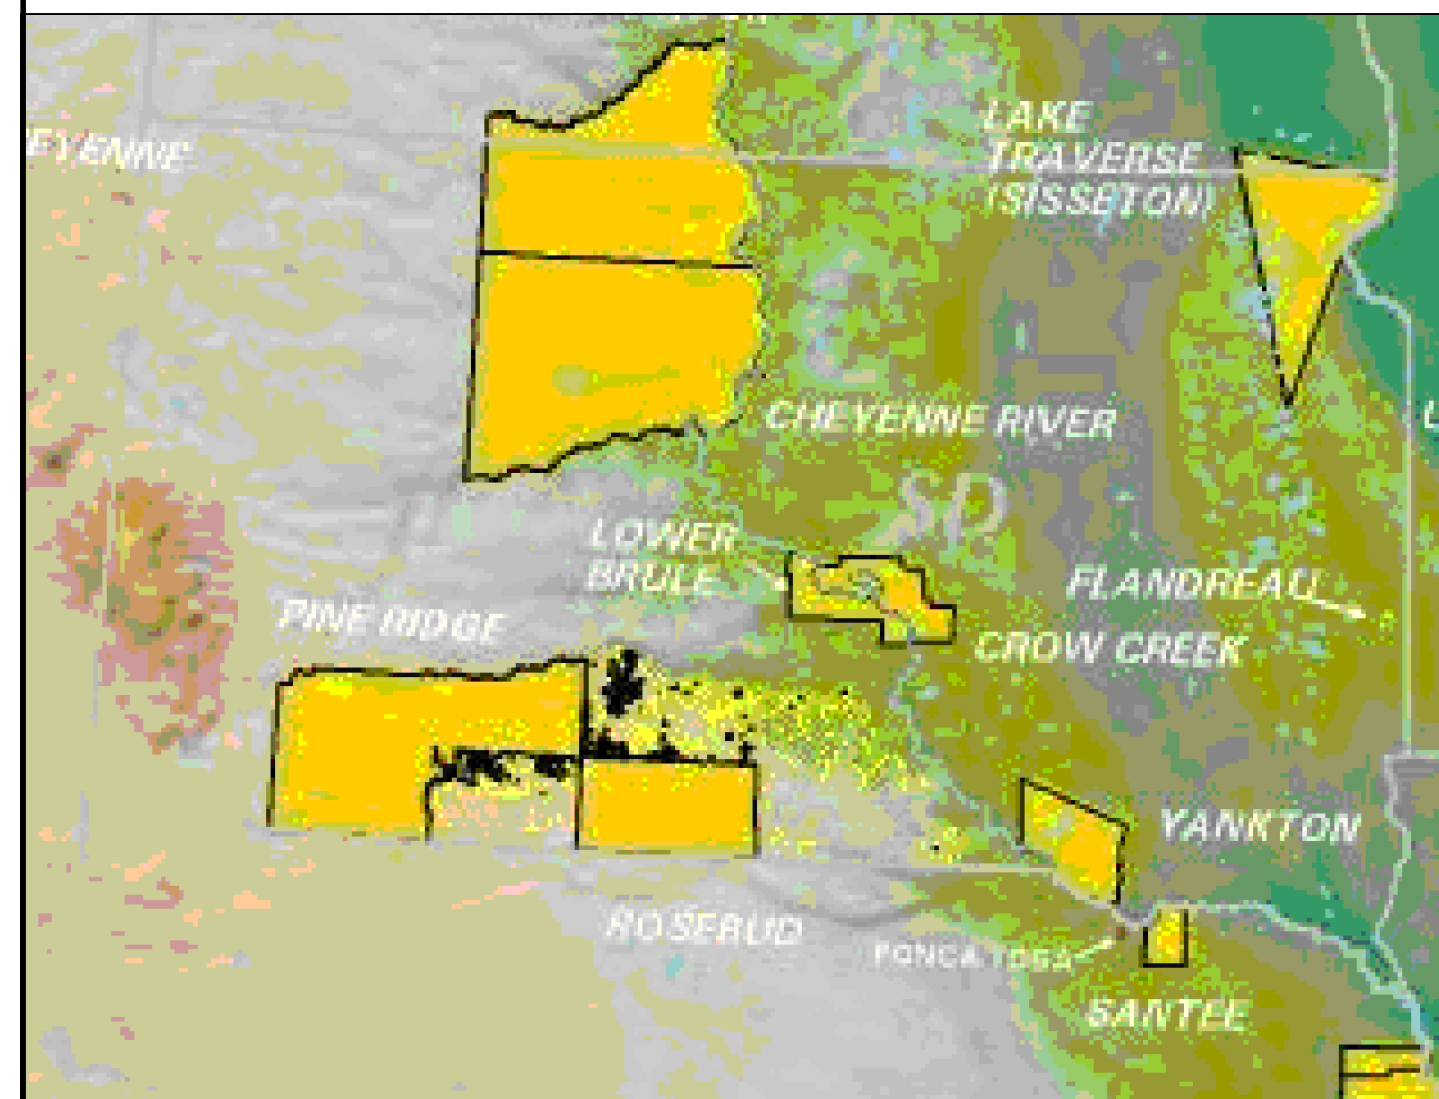

VACINITY MAP
YANKTON SIOUX TRIBE

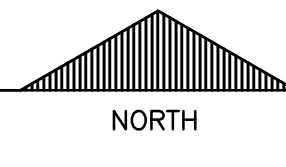

LOCATION MAP
SOUTH CENTRAL SD

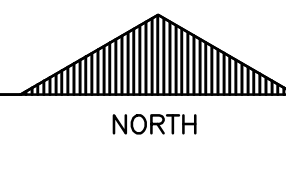

INDEX OF DRAWINGS


SEQUENCE NUMBER	DRAWING NUMBER	DESCRIPTION	SEQUENCE NUMBER	DRAWING NUMBER	DESCRIPTION
1	T1.0	TITLE SHEET			ARCHITECTURAL
2	T2.0	ABBREVIATIONS & GUIDELINES			BUILDING 401GT ELEMENTARY SCHOOL
			42	A1.0	FLOOR PLAN
3	SS1.1	SITE SURVEY - PART 1			BUILDING 90000E BOYS DORMITORY
4	SS1.2	SITE SURVEY - PART 2	43	A2.0	FLOOR PLANS AND DETAILS
5	SS1.3	SITE SURVEY - PART 3	44	A2.1	FLOORING PLAN
6	SS1.4	SITE SURVEY - PART 4	45	A2.2	CEILING PLAN
7	C1.1	TYPICAL ROADWAY SECTIONS			BUILDING 90000H GIRLS DORMITORY
8	C1.2	HORIZONTAL ALIGNMENT - NOTES	46	A3.0	BASEMENT FLOOR PLAN AND DETAILS
9	C1.3	ROADWAY LAYOUT	47	A3.1	FIRST & SECOND FLOOR PLAN AND DETAILS
10	C1.4	BIA HWY 34 1 of 3			BUILDING 90000I OFFICE
11	C1.5	BIA HWY 34 2 of 3	48	A4.0	FLOOR PLANS AND DETAILS
12	C1.6	BIA HWY 34 3 of 3	49	A4.1	WINDOW DETAILS
13	C1.7	CONNECTER ROAD 1 of 3			BUILDING 90000J MIDDLE SCHOOL
14	C1.8	CONNECTER ROAD 2 of 3	50	A5.0	FLOOR PLANS AND DETAILS
15	C1.9	CONNECTER ROAD 3 of 3	51	A5.1	DETAILS
16	C1.10	MAINTENANCE DRIVE			BUILDING 900000A HIGH SCHOOL
17	C1.11	BUS LOOP	52	A6.0	FLOOR PLAN
18	C1.12	PARKING LOT - G	53	A6.1	FLOOR PLAN AND DETAILS
19	C1.13	BIA HWY 30 1 of 3			
20	C1.14	BIA HWY 30 2 of 3			MECHANICAL
21	C1.15	BIA HWY 30 3 of 3	54	M0.1	MECHANICAL COVER SHEET
22	C1.16	PROFILES - CONNECTER and MAINTENANCE	55	M1.1	GYM AREA PLAN BLDG 900000A
23	C1.17	CIVIL DETAILS	56	M2.1	DEMO PLANS BLDG 900000A
24	C1.18	CIVIL DETAILS	57	M2.2	FLOOR PLANS BLDG 900000E
25	C1.19	CIVIL DETAILS	58	M3.1	BASEMENT PLAN BLDG 900000H
26	C2.1	SITE REMODEL PLAN	59	M4.1	FLOOR PLANS BLDG 900000I
27	C2.2	SITE REMODEL PLAN	60	M5.1	DEMO PLANS BLDG 900000J
28	C2.3	BASEBALL FIELD DETAILS	61	M5.2	FLOOR PLANS BLDG 900000J
29	C3.1	STEAM TUNNEL PLAN	62	M6.1	DIAGRAMS AND CONTROLS
30	C3.2	STEAM TUNNEL VAULT PLAN			ELECTRICAL
31	C3.3	STEAM TUNNEL PICTURES			ELECTRICAL COVER SHEET
32	C3.4	STEAM TUNNEL PICTURES	63	E0.1	ELECTRICAL COVER SHEET
33	C3.5	STEAM TUNNEL DETAILS	64	E1.1	OVERALL PLAN BLDG 900000A
34	C4.1	WATER LINE DISTRIBUTION SYSTEM LOOP -1-	65	E1.2	BOILER ROOM PLAN BLDG 900000A
35	C4.2	WATER LINE DISTRIBUTION SYSTEM LOOP -2-	66	E1.3	GYM AREA PLANS BLDG 900000A
36	C4.3	WATER LINE DISTRIBUTION SYSTEM LOOP -3-	67	E2.1	DEMO PLANS BLDG 900000E
37	C4.4	WATER DISTRIBUTION SYSTEM DETAILS	68	E2.2	FLOOR PLANS BLDG 900000E
38	C4.5	WATER DISTRIBUTION SYSTEM DETAILS	69	E3.1	BASEMENT PLAN BLDG 900000H
39	C5.1	SANITARY SEWER COLLECTION 1	70	E4.1	FLOOR PLANS BLDG 900000I
40	C5.2	SANITARY SEWER COLLECTION 2, 3 and 4	71	E5.1	DEMO PLANS BLDG 900000J
41	C5.3	SANITARY SEWER DETAILS	72	E5.2	FLOOR PLANS BLDG 900000J
			73	E6.1	ONE-LINE DIAGRAM
			74	E6.2	ONE-LINE DIAGRAM
			75	E6.3	SCHEDULES



SITE MAP
NOT TO SCALE



PROFESSIONAL STAMPS

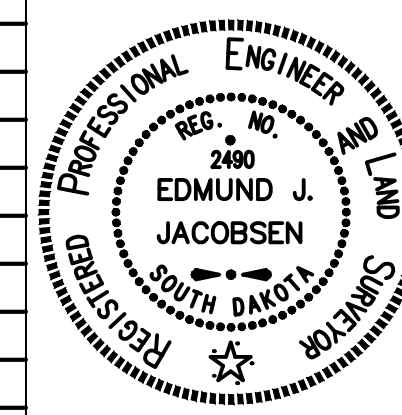

Seal is placed on this sheet electronically. Original is dated and signed. Copies made from original also show date and signature. EXPIRES 12/31/2011

